


Dec 18, 2006 - 12:01pm
 R:\Dwg\Jct-city of\2004\SS Facilities Plan 971.3160.D\Figures\FIGURE 4-5.dwg (8.5x11 tab)

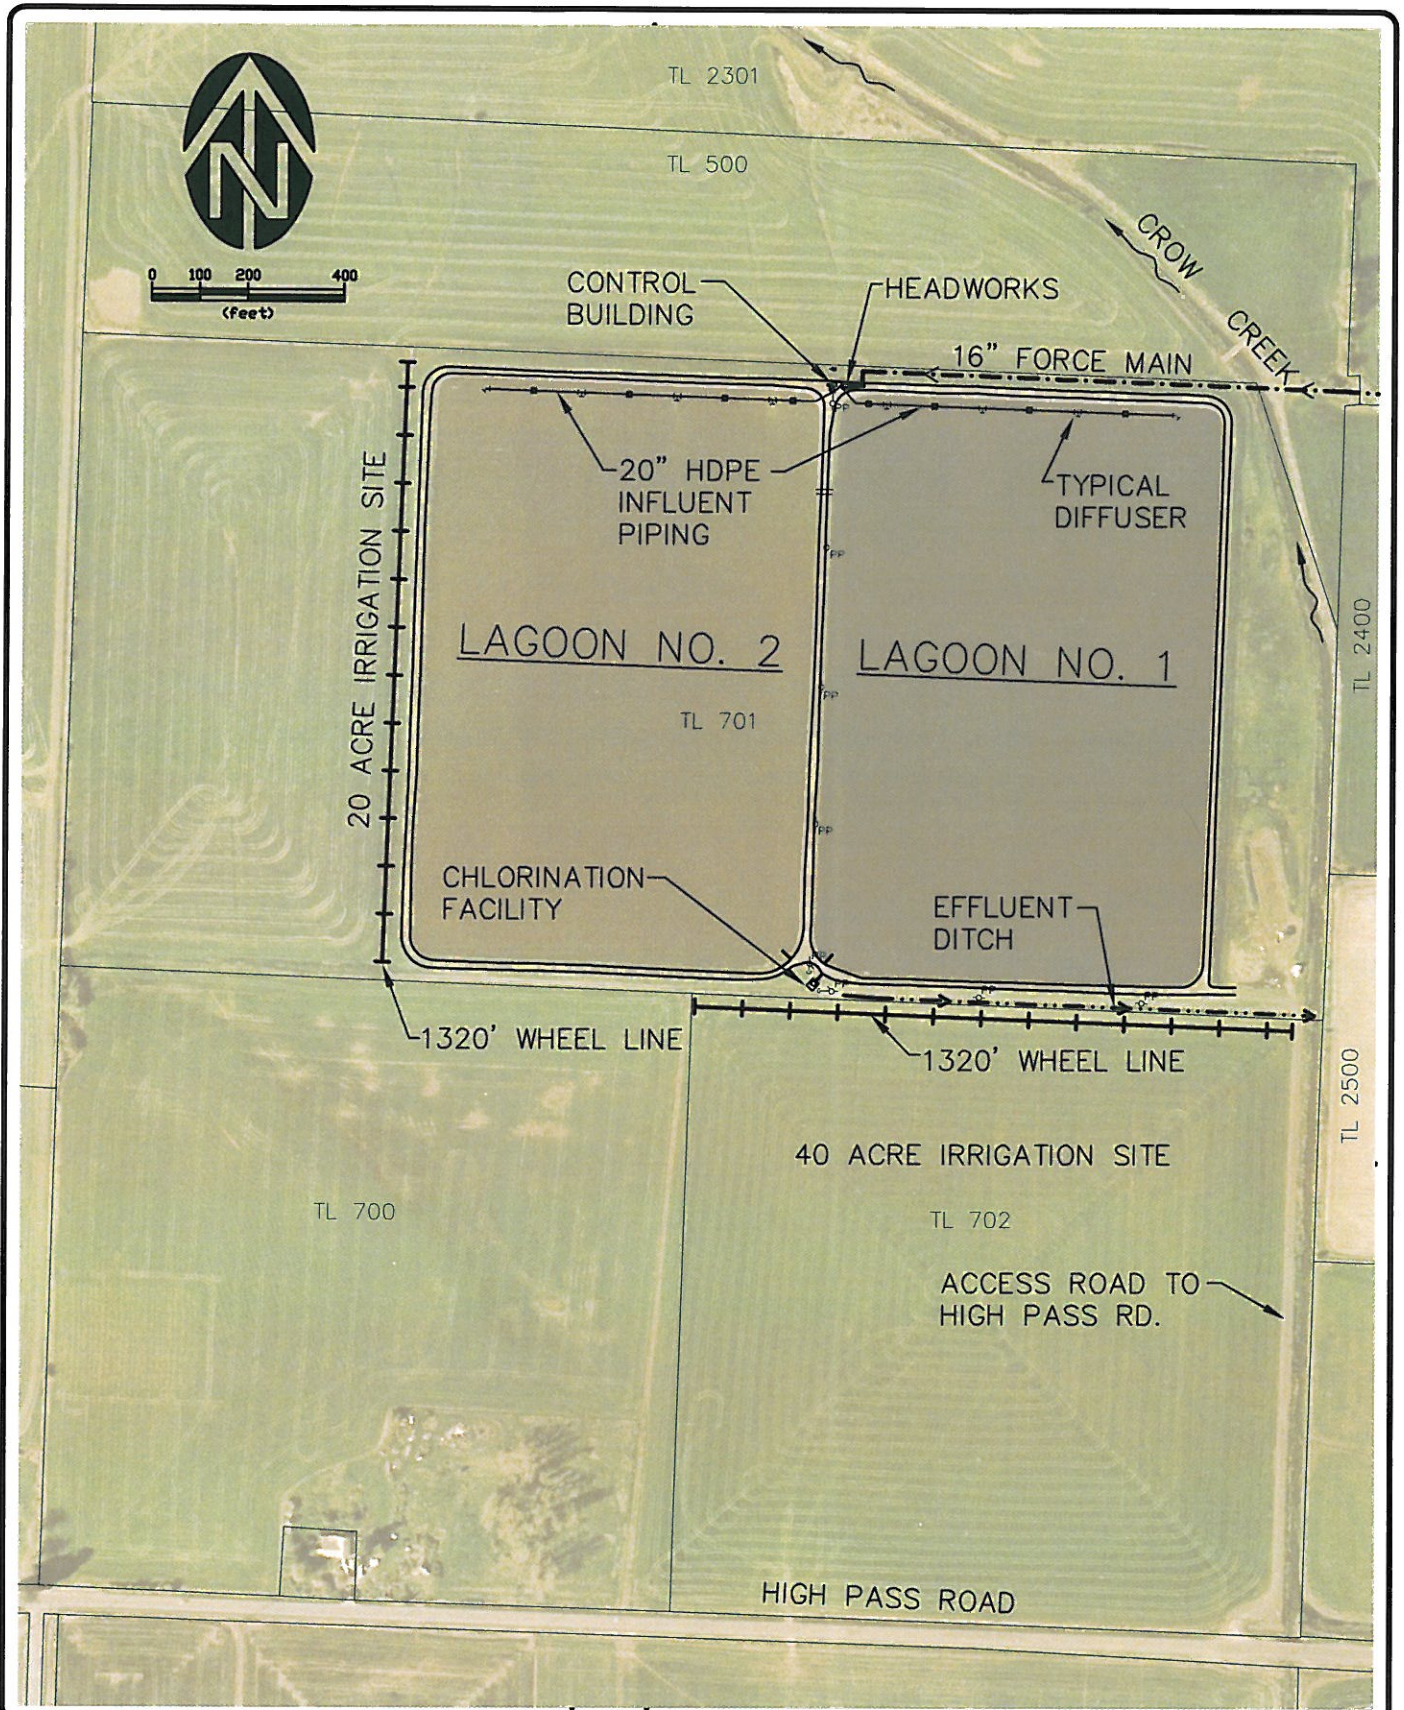

WESTECH ENGINEERING, INC.
 CONSULTING ENGINEERS AND PLANNERS

3841 Fairview Industrial Dr. S.E., Suite 100, Salem, OR 97302
 Phone: (503) 585-2474 Fax: (503) 585-3986
 E-mail: westech@westech-eng.com

SCALE
 HORIZ: 1"=300'
 VERT:
 DSN: CB
 DRN: TMT
 CKD: CB
 DATE: MAR '05

JUNCTION CITY SANITARY SEWER FACILITIES PLAN

EXISTING WASTEWATER TREATMENT FACILITY SITE PLAN

FIGURE

4-5

JOB NUMBER

971.3160.0